


Luminaire Location Summary						
LumNo	Label	X	Y	Z	Orient	Tilt
1	SL6-FT	10.9	18.7	10	45	0
2	SL6-FT	24.7	18.7	10	135	0
3	SL6-FT	11.1	-1.3	10	315	0
4	SL6-FT	24.6	-1.3	10	225	0
Total Quantity: 4						

NOTE:
Actual results achieved may vary from predicted values due to normal deviation in luminaire installation, electrical supply, equipment tolerances, obstructions including poles, brackets and mounting arms, reflectances etc.

This design is for general guidance only & its use is subject to conditions (available on request).

Based On
Lumen Output at 2000 Hours,
Lumen Output per Lamp Manufacturers Data,
Spot Lamp Replacement,
Normal Environment,
Annual Cleaning,
Ground is Level.

VeeLite		
Project: Single Tennis Court		
Project No: 17-11-38	Drawing No: 17-11-38-01A	Drawn By: JF
Date: 27/11/2017	Scale: As shown	REV NO: A
17-11-38-01A.AGI		

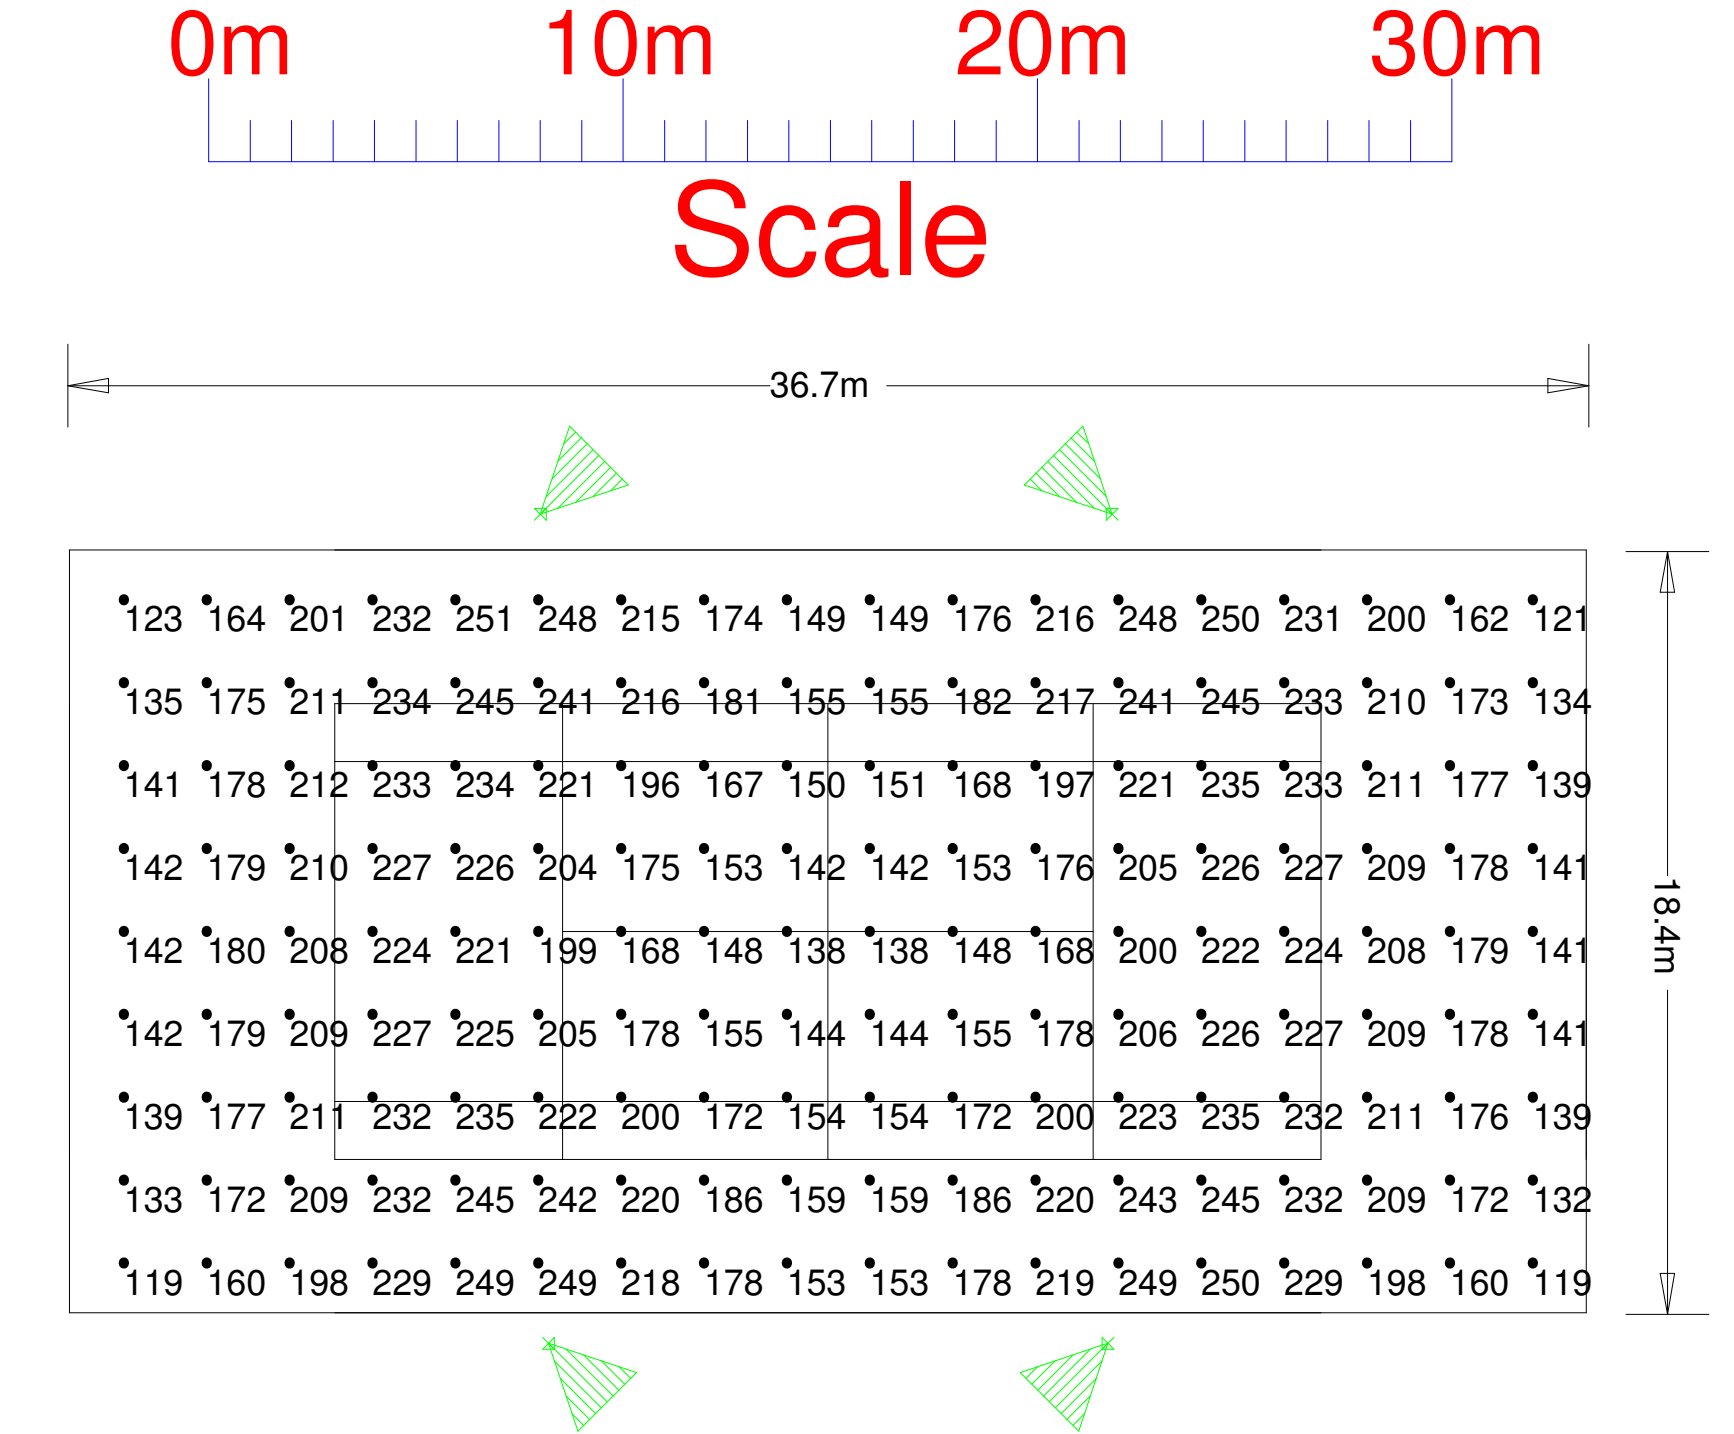

Luminaire Schedule						
Symbol	Qty	Label	Lumens/Lamp	LF	Description	Filename
	4	SL6-FT	72284	0.900	SportsLite 600w LED - Forward Throw	FL06-600 5000K Ra7

Calculation Summary										
Description	Avg	Max	Min	Min/Avg	Min/Max	Units	PtSpcLr	PtSpcTb	# Pts	
Court	191.63	251	119	0.62	0.47	Lux	2	2	162	