


Calculation Summary									
Description	Avg	Max	Min	Min/Avg	Min/Max	Units	PtSpcLr	PtSpcTb	# Pts
Playing Area 24 x 11m	326.31	434	233	0.71	0.54	Lux	3	2.75	45
Total Area 36 x 18m	305.25	443	182	0.60	0.41	Lux	2.2	2	144

Luminaire Schedule									
Symbol	Qty	Label	Lum. Lumens	MF	Description	Filename			
	12	A24	32463	0.900	AkraLED 240w LED, 4K, Asymmetric	5SF240LBA.ies			

Luminaire Location Summary						
LumNo	Label	X	Y	Z	Orient	Tilt
1	A24	-10	9	8	225	0
2	A24	-9.5	9	8	270	0
3	A24	-9	9	8	310	0
4	A24	9	9	8	230	0
5	A24	9.5	9	8	270	0
6	A24	10	9	8	315	0
7	A24	-10	-9	8	135	0
8	A24	-9.5	-9	8	90	0
9	A24	-9	-9	8	50	0
10	A24	9	-9	8	130	0
11	A24	9.5	-9	8	90	0
12	A24	10	-9	8	45	0
Total Quantity: 12						

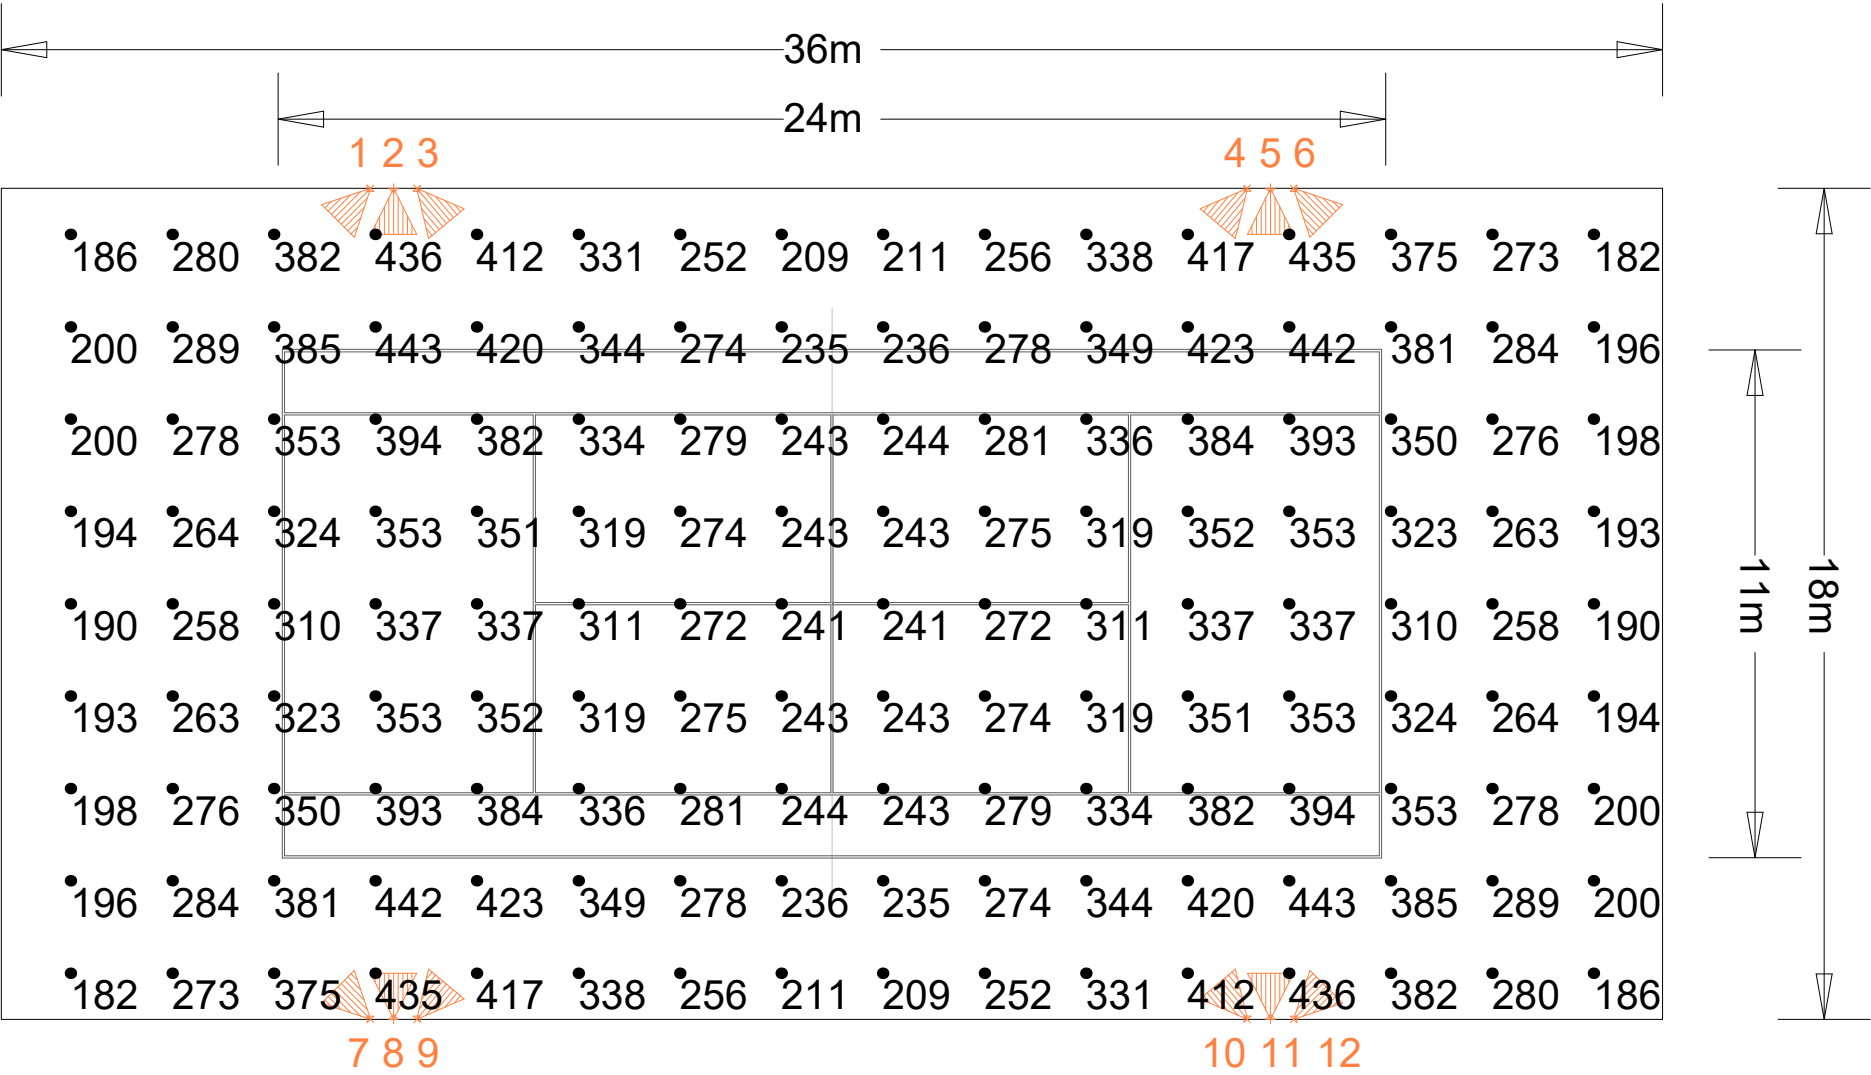

NOTE:
Actual results achieved may vary from predicted values due to normal deviation in luminaire installation, electrical supply, equipment tolerances, obstructions including poles, brackets and mounting arms, reflectances etc.

This design is for general guidance only & its use is subject to conditions (available on request).

Based On
Lumen Output at 20000 Hours,
Spot Lamp Replacement,
Normal Environment,
Annual Cleaning,
Ground is Level.

VeeLite		
Project: Standard Tennis Court Class 2 300 Lux 0.7 Uniformity		
Client: Veelite		
Project No: VL-STC	Drawing No: VL-STC-CL2	Drawn By: GK
Date: 27/09/2023	Scale: As shown	REV NO: A
Single Tennis Court 300lux 8m.AGI		